



10411 Meeting Street
 Louisville, KY 40059
 F. 859.326.2691
 T. 502.326.3085
 postmaster@cmsitegrs.com

ENERGY SOLUTIONS
cmsitegrs

MORGAN COUNTY SCHOOLS, WV
 GUARANTEED ENERGY SAVINGS CONTRACT
 MORGAN COUNTY BOARD OF EDUCATION
 BERKELEY SPRINGS, WV
 BUS GARAGE SITE

REVISIONS

A. BIDDING 3/6/2017

DATE: 3/6/2017

DRAWN:

CHECKED:


SET NO.

E4.0

PRICING DOCUMENT ONLY



BUS GARAGE - SITE LIGHTING PLAN
 SCALE 3/32" = 1'-0"

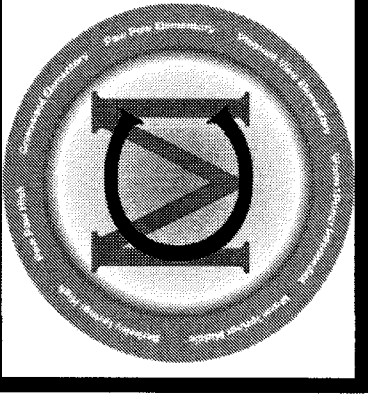

10411 Meeting Street
Louisville, KY 40059
F 859 326.3085
postmaster@cmtegrs.com

ENERGY SOLUTIONS
cmtra


MORGAN COUNTY SCHOOLS, WV
GUARANTEED ENERGY SAVINGS CONTRACT
MORGAN COUNTY BOARD OF EDUCATION
BERKELEY SPRINGS, WV
BUS GARAGE

REVISIONS
A. BIDDING 3/1/2017
DATE 3/1/2017
DRAWN:
CHECKED:
SET NO. <input type="checkbox"/>

E4.1

LIGHTING TAGGED NOTES:

1. INSTALL NEW OCCUPANCY SENSOR AND OCCUPANCY SENSOR POWER PACK / RELAYS IN ALL ROOMS. OCCUPANCY SENSOR AND POWER PACK/RELAYS TO BE PROVIDED BY CM/A. INSTALLED BY CONTRACTOR.

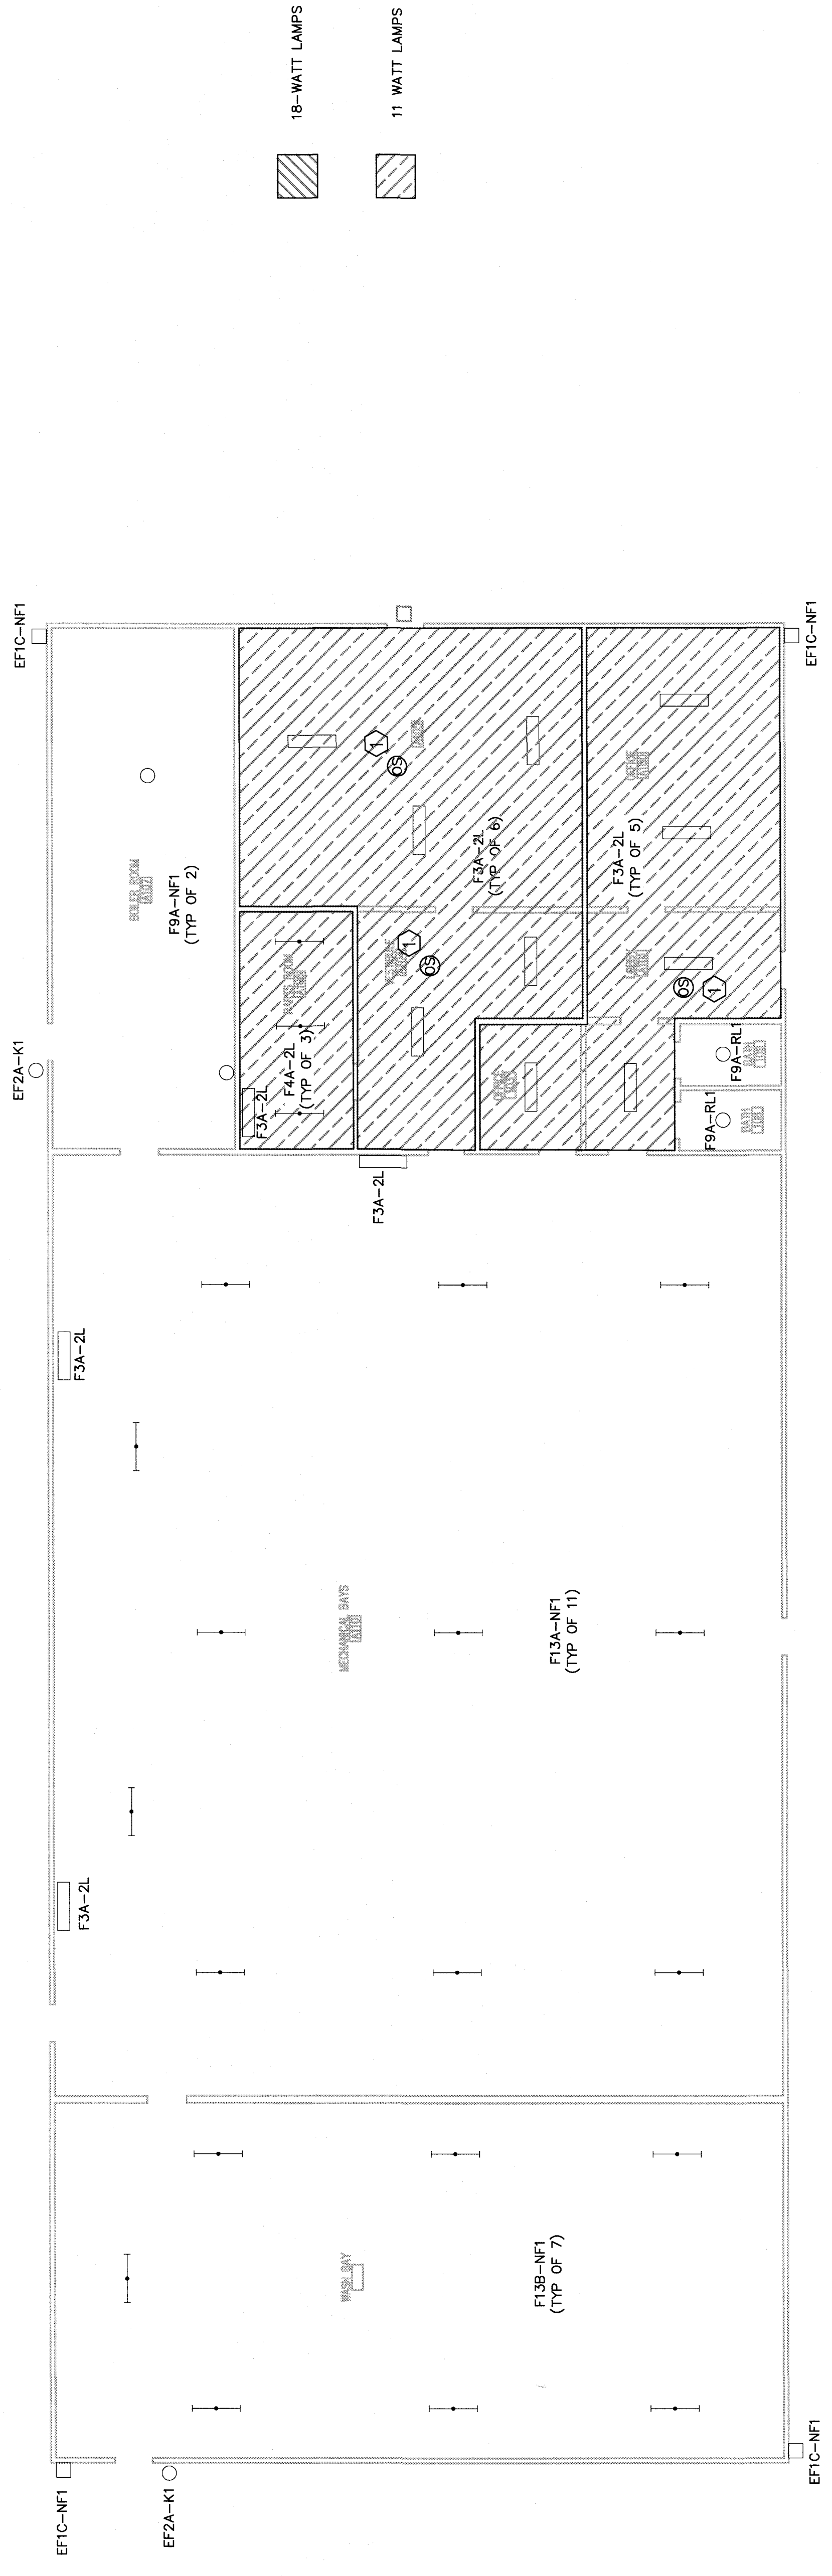

MORGAN COUNTY BUS GARAGE - LIGHTING PLAN
SCALE: 1/8" = 1'-0"